



PLAN NOTES:

- ① CONNECT NEW HEATING HOT WATER LINE FROM NEW PLATE/FRAME HEAT EXCHANGER TO DOMESTIC COLD WATER FILL SYSTEM.
- ② FOR LOW GRADE HOT WATER PIPING SEE SHEET M2.2

PLUMBING PLAN - SERVICE BUILDING B BOILER ROOM
SCALE: 1/4" = 1' - 0"

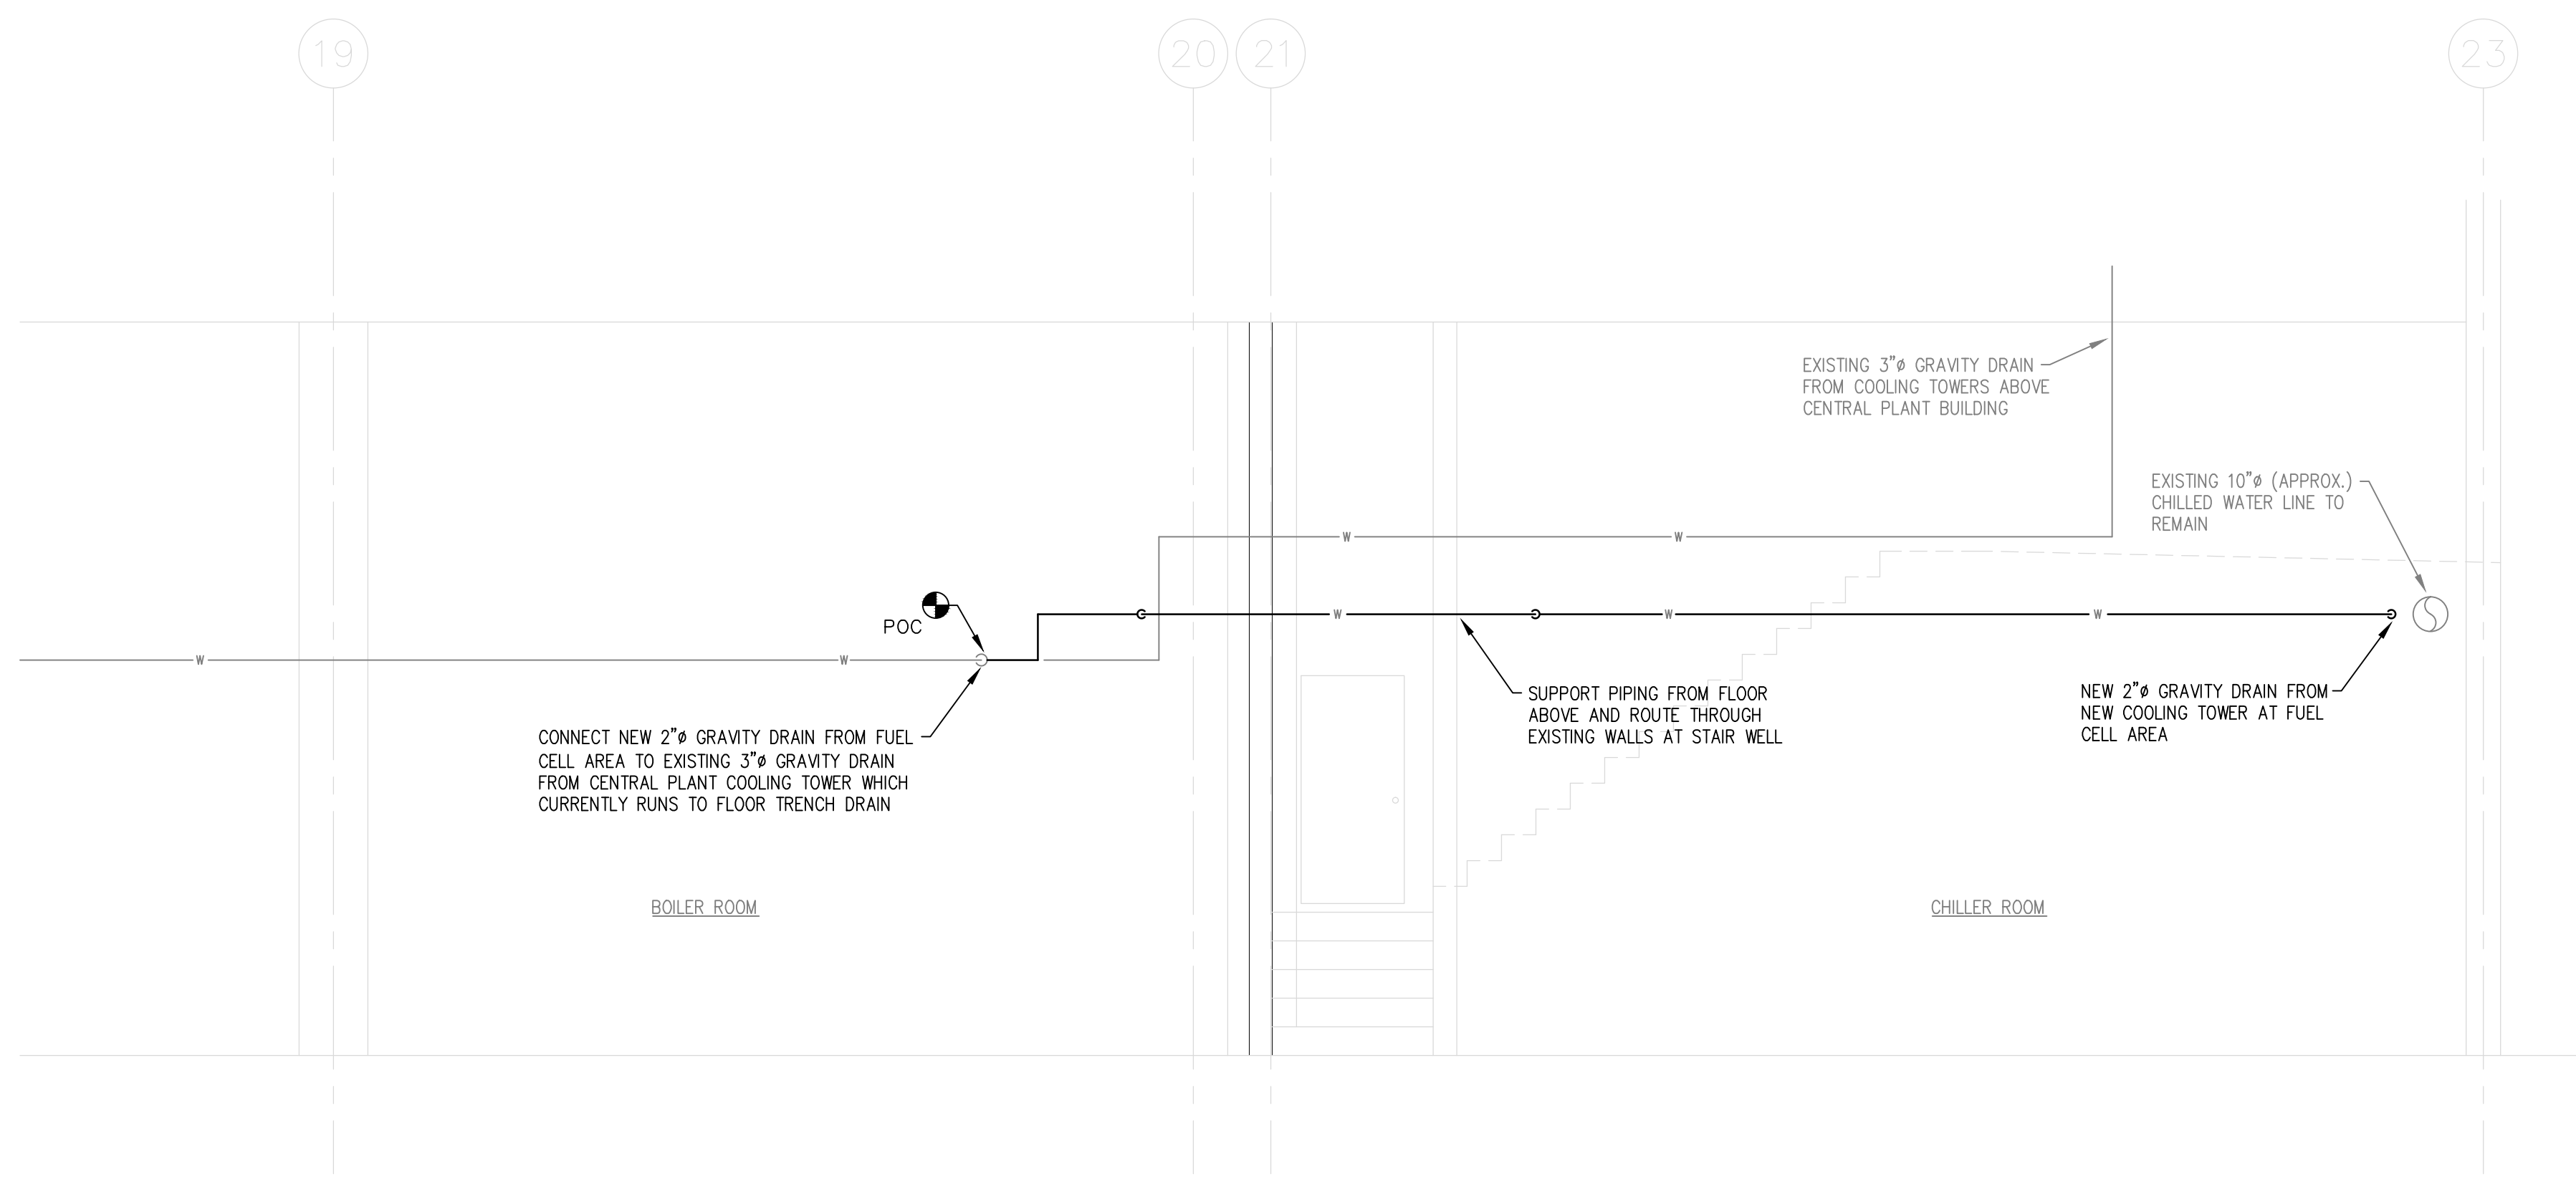

SECTION A-A
SCALE: 1/4" = 1' - 0"

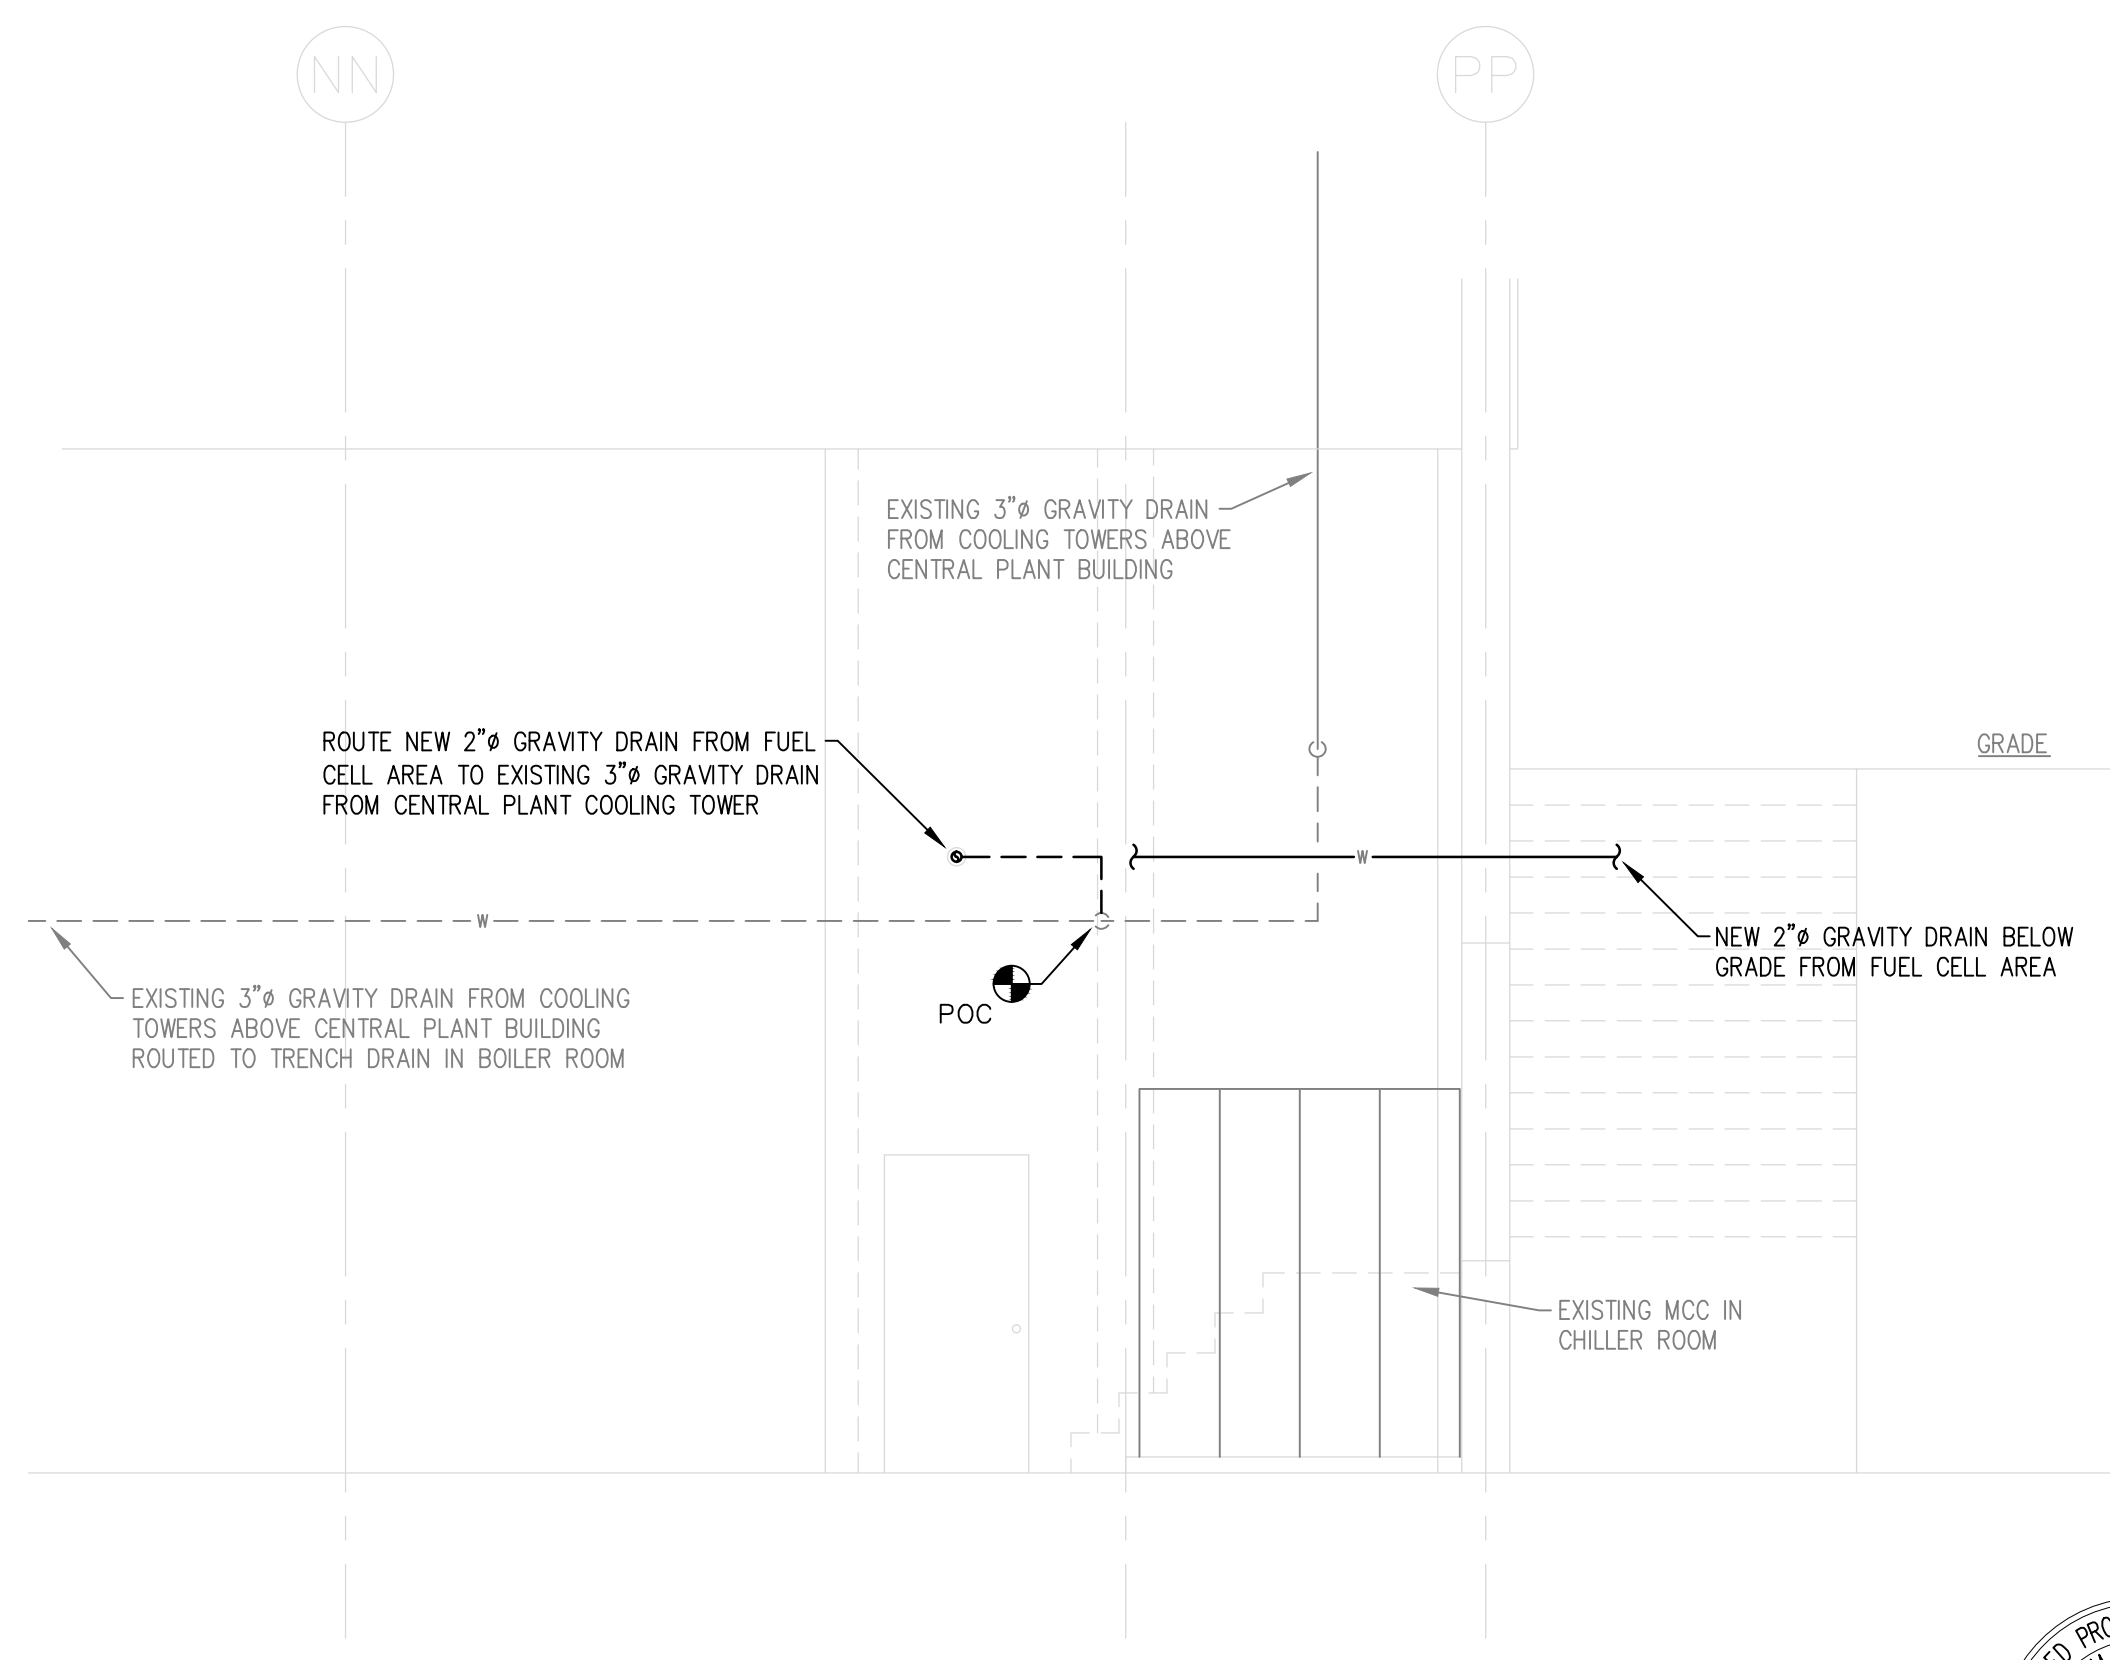

SECTION B-B
SCALE: 1/4" = 1' - 0"



**CBS TELEVISION CITY
FUEL CELL INSTALLATION PROJECT**

7800 BEVERLY BLVD.
LOS ANGELES, CALIFORNIA 90036

PLUMBING PLAN - SERVICE BUILDING B BOILER ROOM AND SECTIONS

ID	DATE	REMARKS
1	7/02/12	PRELIMINARY DESIGN REVIEW
2	8/20/12	PLAN CHECK
3	9/14/12	BD CLARIFICATIONS
4	9/19/12	UTC RECOMMENDED CORRECTIONS
5	9/25/12	UTC COMMENTS/REVISIONS

ENGR:	WTB
DRWN BY:	KAP
CHK'D BY:	WTB
DATE:	9/19/12
JOB NO.:	12-010
SCALE:	AS NOTED

SHEET
M2.4