


TO E1-01
B

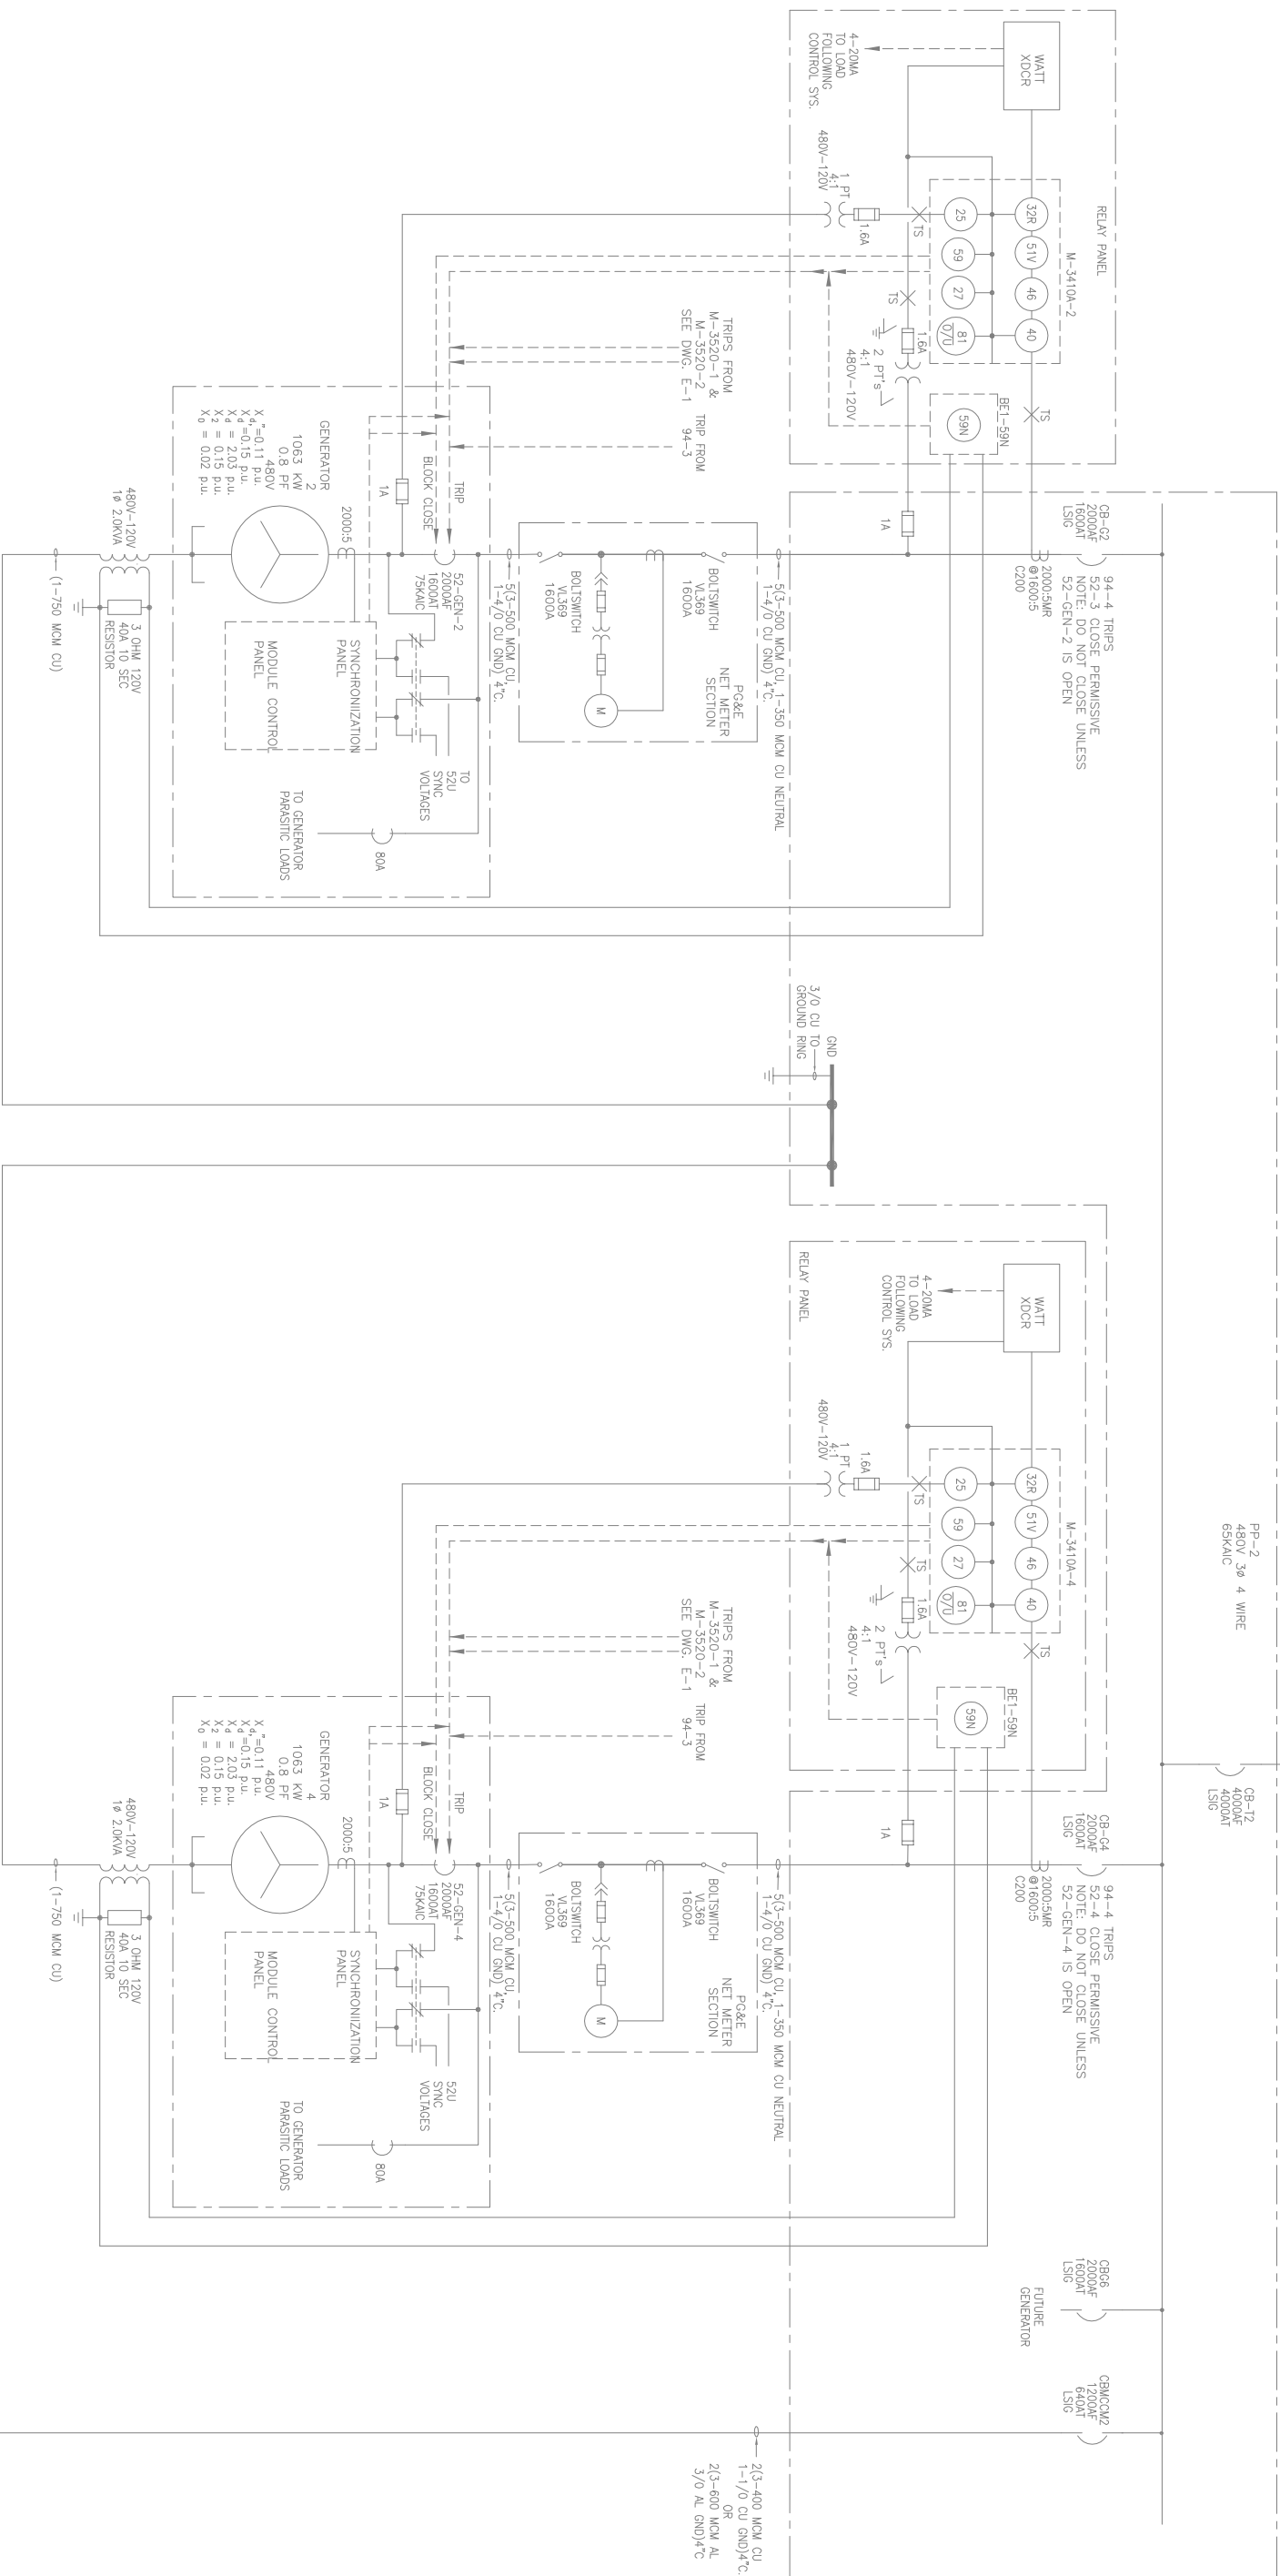

REVISIONS				
NO.	DATE	DWN.	CHK.	
A	11/24/10	KM	KM	FOR REVIEW
B	8/5/11	KM	KM	ISSUED FOR PERMIT
C	7/17/12	GDY	GDY	RECORD DRAWING

GENERATION ADDITION
Colusa Indian Community Council 3730 Highway 45, Colusa, CA 95932

ONE-LINE DIAGRAM

P.O. Box 1265 Arvada, CO 80001
 (303) 431-7895 FAX (303) 431-1836

ENGINEERED BY
KM

DRAWN BY/CHECKED
JLB

DATE
4/11/12

SCALE
N/A

TITLE NO.
2287

E1-04